


TYPICAL LIGHT POLE BASE DETAIL
SCALE: NONE

LIGHT FIXTURE SCHEDULE

PLAN MARK	MANUFACTURER	MODEL NUMBER	MOUNTING	FINISH	LAMP CODE	LAMP QUANTITY	NOTES
AA	MCGRAW-EDISON	GALN-SA2C-740-U-T4FT	20' POLE	BRONZE	108W LED PER HEAD	1	1,2,3,5
BB	MCGRAW-EDISON	GALN-SA2C-740-U-T4FT-20180 DEG	20' POLE	BRONZE	108W LED PER HEAD	2	1,2,3,5
A	LITHONIA	WPX1-LED-P2-30K-MVQLT-E14WC-DOBKD	WALL/SURFACE	BRONZE	24W LED	-	1,2
B	GREEN CREATIVE	12NCDRL6DIM/930/EXT	RECESSED	BLACK	12W LED	-	1,2,3,6
B1	GREEN CREATIVE	12NCDRL6DIM/930/EXT-EM	RECESSED	BLACK	12W LED	-	1,2,3,4,6
C	AFX	BMW517800L30MVZ	WALL/SURFACE	BRONZE	1,800 LUMENS/19W	-	1,2

- NOTES LEGEND
- 1 - PROVIDE WET LOCATION RATED FIXTURE
 - 2 - PROVIDE GOLF LOCATION RATED DRIVER
 - 3 - PROVIDE SQUARE STRAIGHT STEEL POLE RATED FOR 100 MPH WIND GUSTS, PRIMED AND PAINTED TO MATCH FIXTURE
 - 4 - PROVIDE EMERGENCY BATTERY
 - 5 - PROVIDE ALL ACCESSORIES FOR A COMPLETE INSTALLATION.
 - 6 - PROVIDE WEATHER PROOF JUNCTION BOX FOR DRIVERS AND ELECTRICAL CONNECTIONS ABOVE SOFFIT.

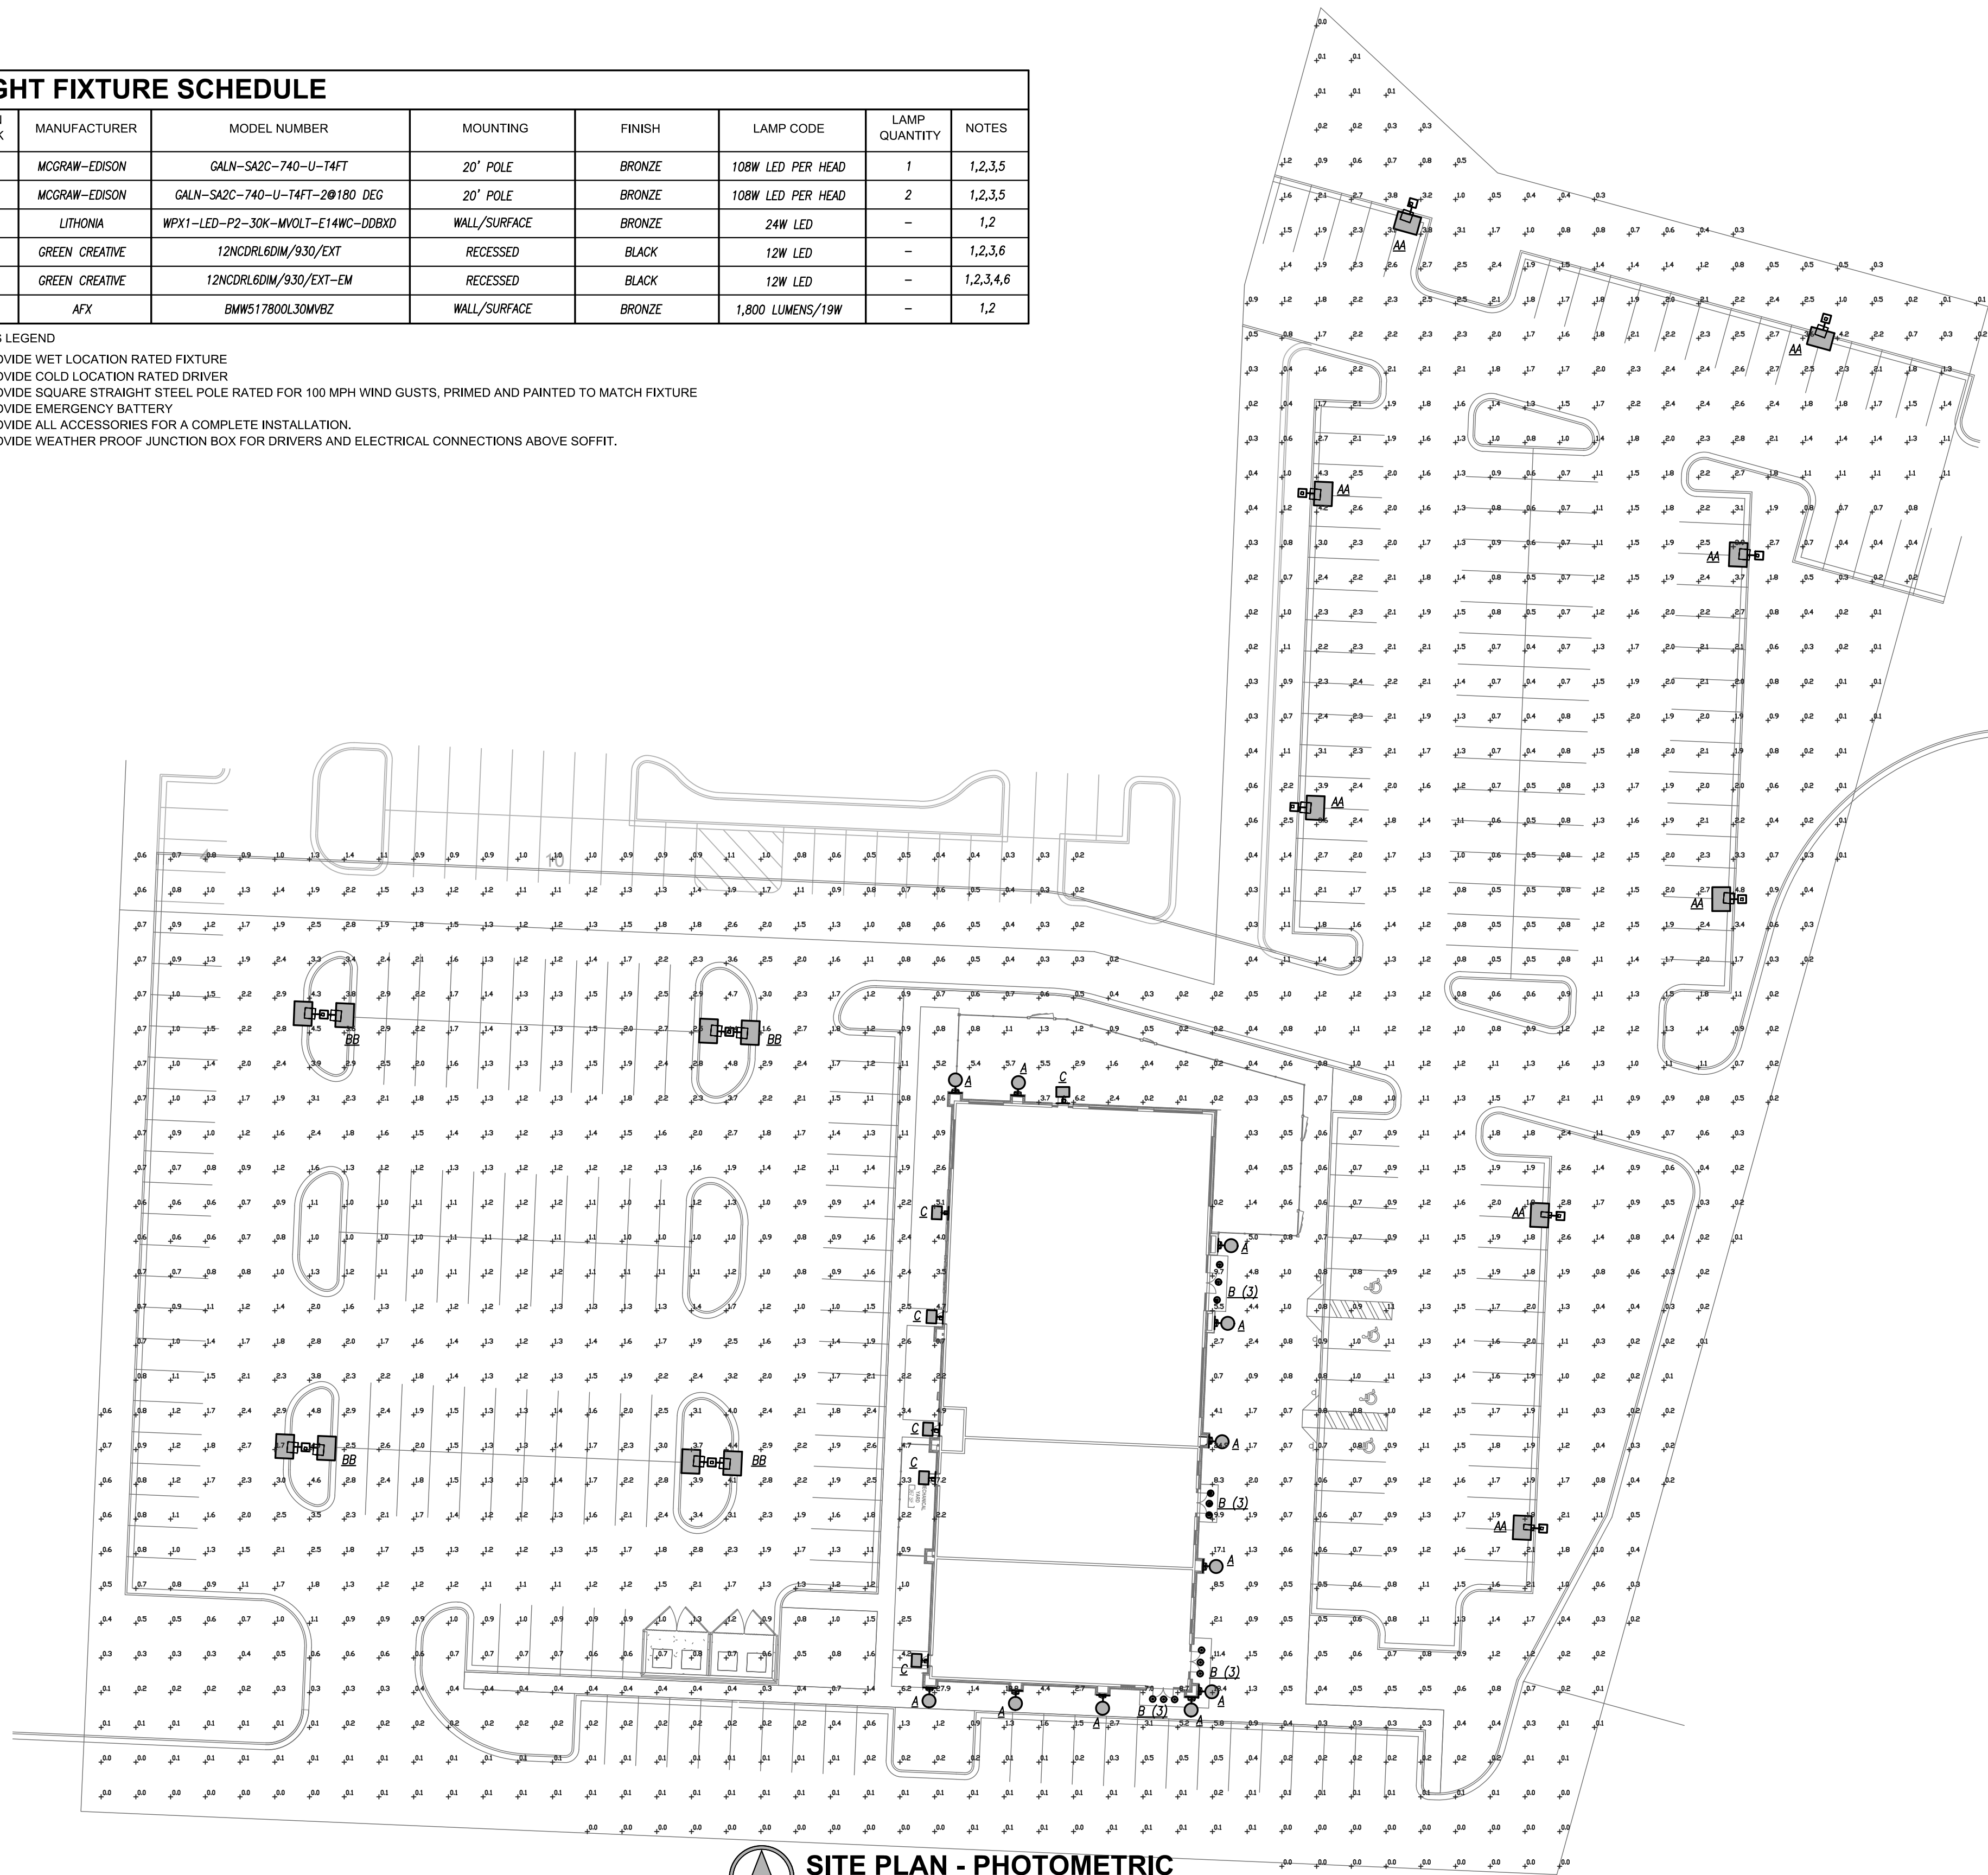

SITE PLAN - PHOTOMETRIC
1" = 30'-0"

schwerdt design group
architecture|interiors|planning
2231 sw wanamaker rd suite 303
topeka, kansas 66614-4275
phone: 785.273.7540
fax: 785.273.7579
500 north broadway suite 200
oklahoma city, ok 73102
phone: 405.231.3105
fax: 405.231.3115

PRELIMINARY
NOT FOR CONSTRUCTION

**CORE & SHELL BUILDING
STREETS OF WEST PRYOR LOT 13
LEES SUMMIT, MISSOURI**

SUBMISSION DATES
JULY 21, 2023

SHEET TITLE
SITE PHOTOMETRIC
PLAN

PROJECT NUMBER
230117

SHEET NUMBER
ME-101

pkmr
ENGINEERS
PEARSON KENT MCKINLEY-RAAF ENGINEERS LLC
2949 SW WANAMAKER DR., TOPEKA, KANSAS 66614
785.273.2447 WWW.PKMRENG.COM

FILE PATH:
DATE:
DRAWN BY: